


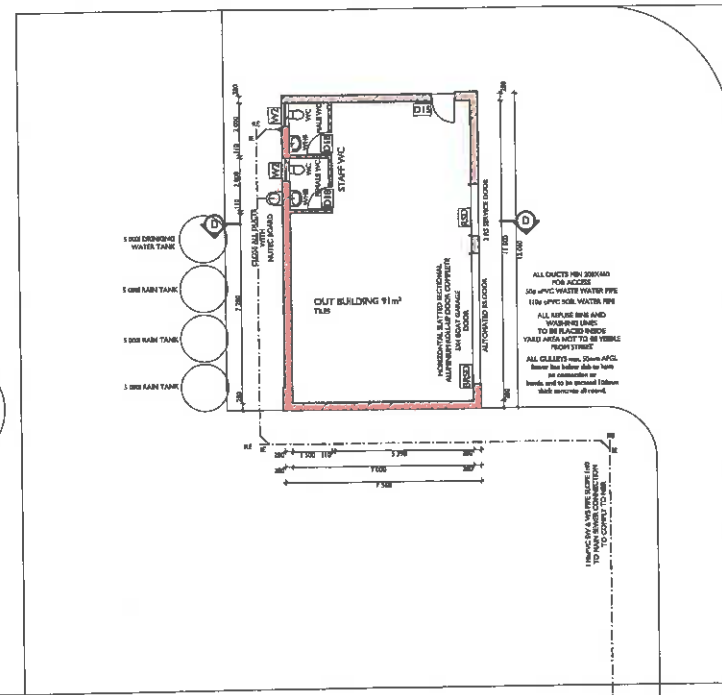

- * All contractors to comply with BS8818 (1990)
- * No dimensions to be scaled or measured from drawing
- * All dimensions to be checked on site
- * Where applicable the Contractor is to check on site size components to be manufactured prior to manufacture
- * Contractor responsible for correct setting out of the buildings, all external and internal walls with particular reference to boundaries, building lines, etc.
- * Contractor to verify all levels, heights and dimensions on site and to check the same against the drawings before putting any work in hand.
- * Contractor is to locate and identify existing services on site and to protect these from damage throughout the duration of the works
- * Any pipes, conduits or cables to be replaced immediately.
- * Contractor is to build in approved 4' x 6' D.P.C. wherever roof eaves are shown on drawings. To make good any rain water, down or guttering and to all standards.
- * Any quantity arising from all the above shall be reported and certified by the contractor's quantity surveyor.

DRAINAGE NOTES

- * All plumbing and drainage work and installation of sanitary fixtures to be done in accordance with the relevant Local Authority by-law, regulations and codes of practice.
- * Provide 1.5% fall to all beams and junctions with suitable means of access from ground level and to be fully accessible at all times.
- * Minimum 1.80 fall to all drain-pipes.
- * Provide approved stand trays to all waste drains.
- * Provide A.S.J. to fit of all steel stacks.
- * All soil pipes passing under buildings or footings to be protected against loads.

COPYRIGHT

* R. Hamilton is the proprietor of all rights including copyrights in this material.

No reproductions are permitted without written consent.

The client accept the responsibility of materials, content and statements. The elements shown on this drawing are preliminary design only. They may not be utilized, altered, the specification changed, or implemented in part, or in whole, in any structure without realization and written approval being issued by the architect.

100

[illegible]

100

[illegible]

1	2	3	466
---	---	---	---	---	---	---	---	---	----	----	-----	-----	
[illegible]

.....

1	2	3	466
---	---	---	---	---	---	---	---	---	----	----	-----	-----	
MOORE, JAY MUNICIPALITY / MOOREMAN, JAMES
PLANE, T. J. RECOMMENDED FOR APPROVAL TO BECOME
ONE OF 1975 AND 1976 MOOREMAN, T. J. AND ONE OF 1976 AND 1977

APPROVED BY SECTION 7 OF ACT 108 OF 1877 /
GOVERNMENT OF ALABAMA, ARTICLE 7 JAN 1877 108 1877
SUBJECT TO CONFIRMATION BY LEGISLATURE ON PLAN AND LETTER OF APPEAL

THIS APPROVAL IS VALID FOR 18 MONTHS
 HEADLINE GOODWILLING IS VALID FOR 12 MONTHS

DATE: 11/23/01

11. **ADDITIONAL INFORMATION / NOTES:**

[illegible][illegible]

1980

2025

SCANNED
MOORE HILL MUNICIPALITY / MOORE HILL MUNICIPALITY

PLAN NO. 214152
 ALLE WERKEN MOET VOLDOEN AAN HET BEELT 1907. EENS
 ALLE RELEVANTE WETGEVING. RAADSGELIC
 RAADSGEGEVINGEN VOORWAARDEN MOET BY
 WETKOM WORD.

CLIENT

ALL WORK TO COMPLY WITH ACT 166 OF 1975, STATE
AND ALL RELEVANT REGULATIONS, ORDINANCES, RESOLUTIONS
COUNCIL ORDINANCE OF APRIL 24, 1987, E.E. COMPLIANT

ENGINEER

[illegible]

APR 1960

NO.	DATE	REVISIONS

[illegible][illegible]

DRAWING STATUS
MUNICIPAL DRAWINGS

PROJECT TITLE
NEW RESIDENTIAL HOUSE

FOR NEW BEGINNING 17 (P
LTD - GROOT BRAK
ERF 4 716

	DRAWING DESCRIPTION
--	---------------------

FLOOR PLAN PERSPECTIVES

SCALE	AS SHOWN
DATE	MARCH 2023

ISSUED	24/03/2023
DRAWN BY	RH
CHECKED BY	TwlR

ARCHITECT	Tydb
-----------	------

RHAP




Ryan Hamilton Architectural De

CONTACT:
072 394 0427 (R.Hamilton)
r.hamilton@btinternet.com

POSTAL & WORK ADDRESS:
57 Ashland
2007 Kings Avenue E. Chino

PROJECT NO:	DRAWING NO:	REVISION:
-------------	-------------	-----------

A.21.010	MDU1	REV
----------	------	-----

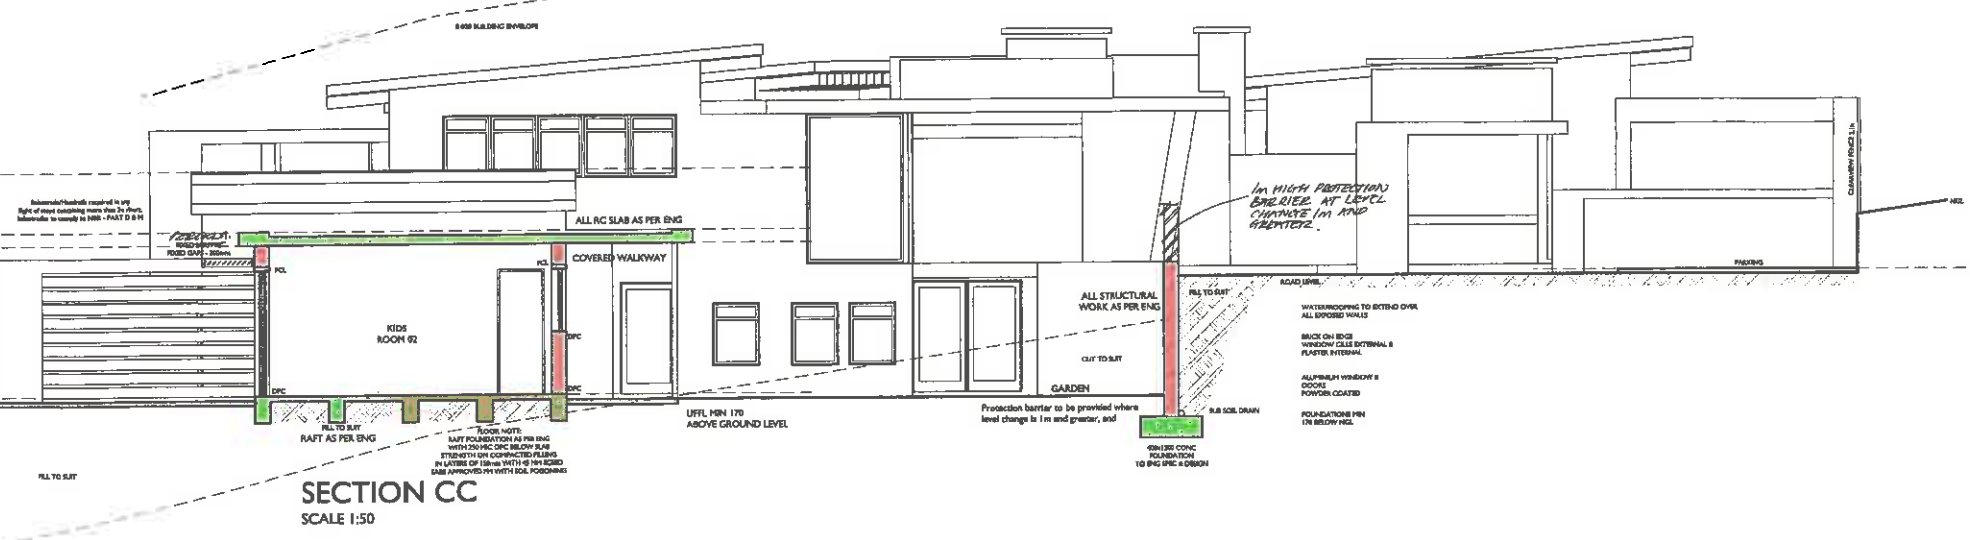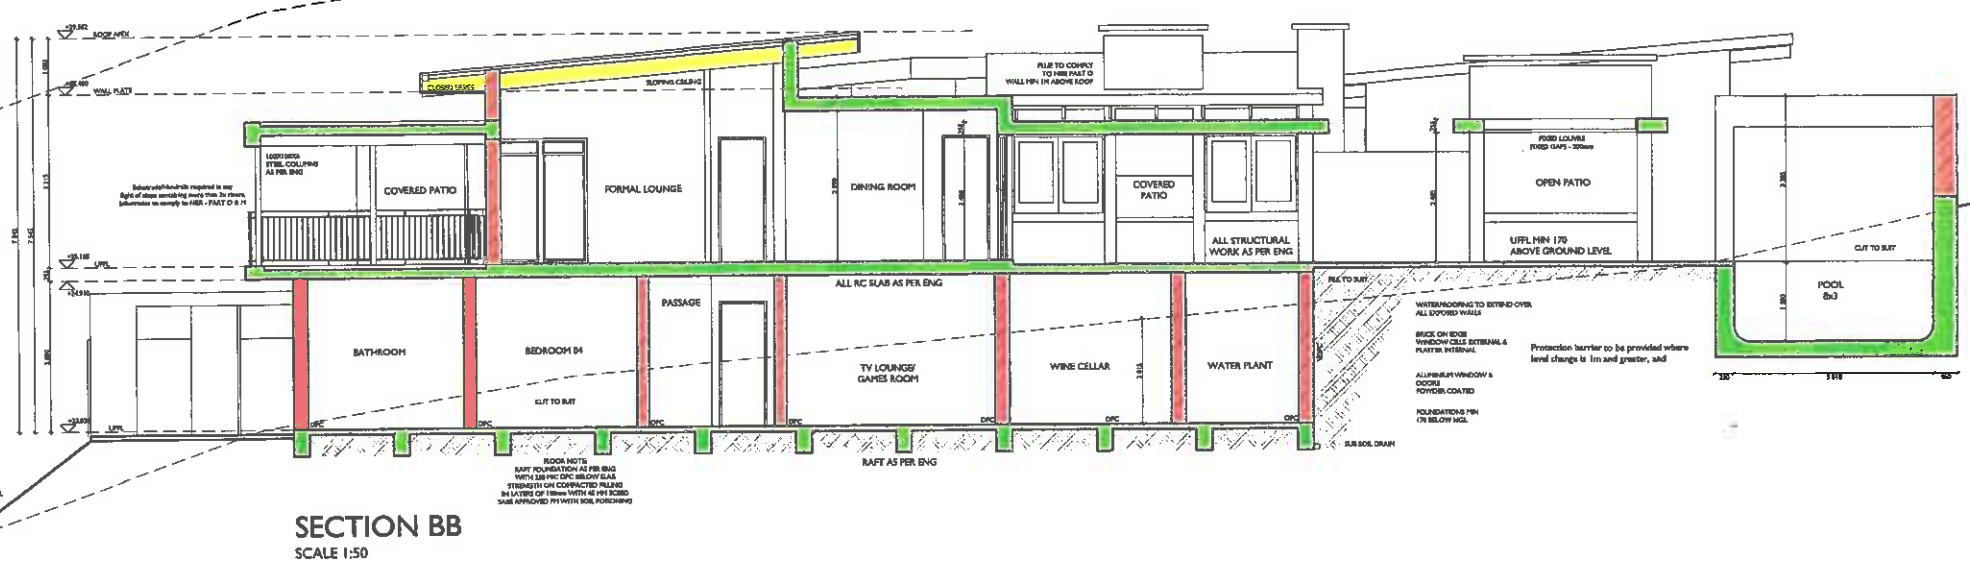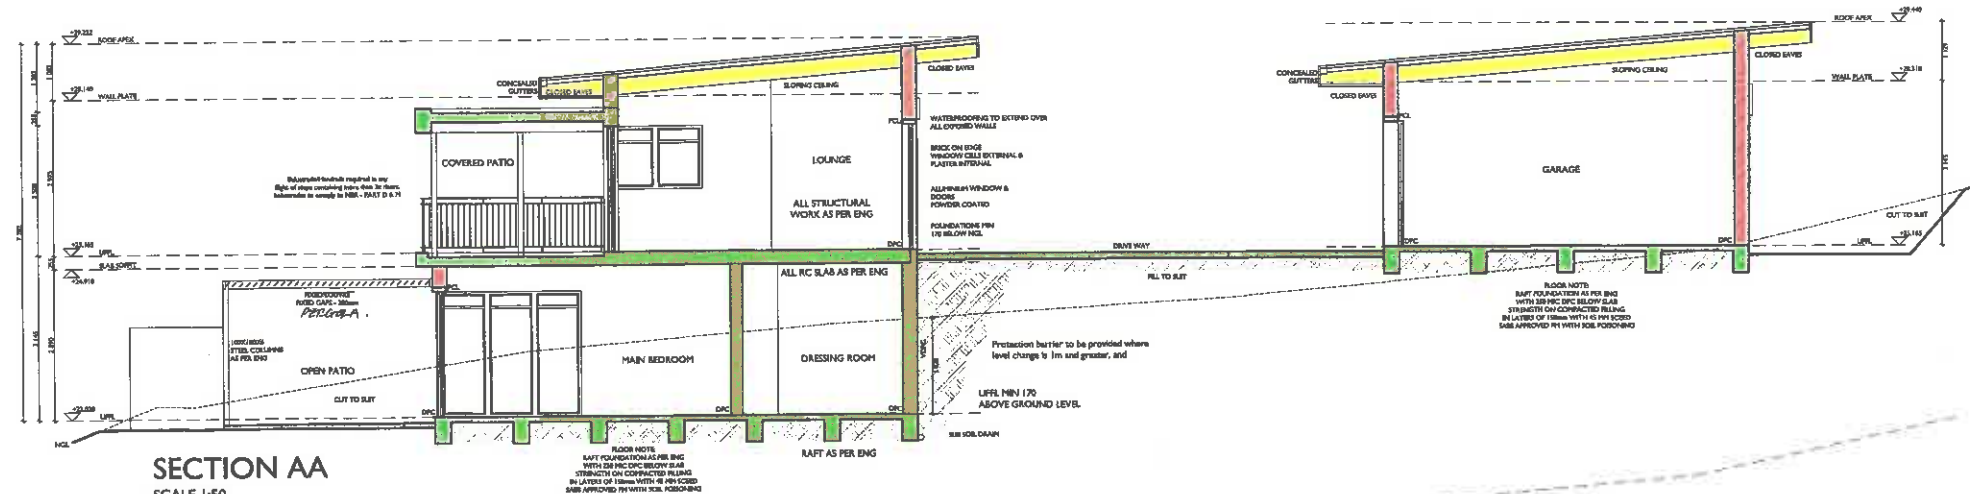

GENERAL NOTES

- All building work to comply with SABS 3000.
- No dimensions to be scaled or estimated from drawing.
- All dimensions to be checked on site.
- Where applicable the contractor is to check on site.
- Contractor is responsible for correct setting out of the building, all external and internal walls with particular reference to boundaries, building lines, etc.
- Contractor to verify all levels, heights and dimensions on site and to check the same against the drawings before putting any work in hand.
- Contractor is to be liable and directly answerable for the site and to protect these from damage throughout the duration of the works.
- Any work, excavation or construction is to be reported immediately.
- Contractor is to be approved 4 days prior to start of work or not to start work on drawings, in all cases at least 4 days prior to start of work and in all cases, doors, pillars or other openings in external walls.
- Any work starting from the above must be reported and checked before any work is put in hand.

DRAINAGE NOTES

- All planning and drainage work and installation of sanitary fittings to comply with the relevant Local Authority by-laws, regulations and requirements.
- Provide 1% fall to all drains and junctions with suitable manholes at ground level and to be fully accessible at all times.
- Manholes 1000 mm dia to be used.
- Provide approved material pipes to all waste fittings.
- Provide 1% fall to all waste fittings.
- All soil pipes passing under buildings or footings to be protected against loads.

COPYRIGHT

© 2023 by the proprietor of all rights including copyright in this drawing. No reproduction is permitted without written consent. The drawing is the property of the proprietor and is not to be used for any other purpose without the written consent of the proprietor. The drawing is the property of the proprietor and is not to be used for any other purpose without the written consent of the proprietor.

SCANNED
2023-04-25

CLIENT
NEW BEGINNING 17 (PTY) LTD - GROOT BRAK ERF 4716

ENGINEER
R.HAD

DRAWING STATUS
MUNICIPAL DRAWINGS

PROJECT TITLE
NEW RESIDENTIAL HOUSE FOR NEW BEGINNING 17 (PTY) LTD - GROOT BRAK ERF 4716

DRAWING DESCRIPTION
SECTIONS

SCALE
AS SHOWN

DATE
MARCH 2023

ISSUED
24/03/2023

DRAWN BY
R.H.


CHECKED BY
T.W.B.

ARCHITECT
T.W.B.


RFAD
Ryan Hamilton Architectural Design

CONTACT
071 234 4427 (mobile) 071 234 4427 (home) 071 234 4427 (work) 071 234 4427 (fax)

PROJECT NO: A.21.010 **DRAWING NO:** MD03 **REVISION:** REV 01

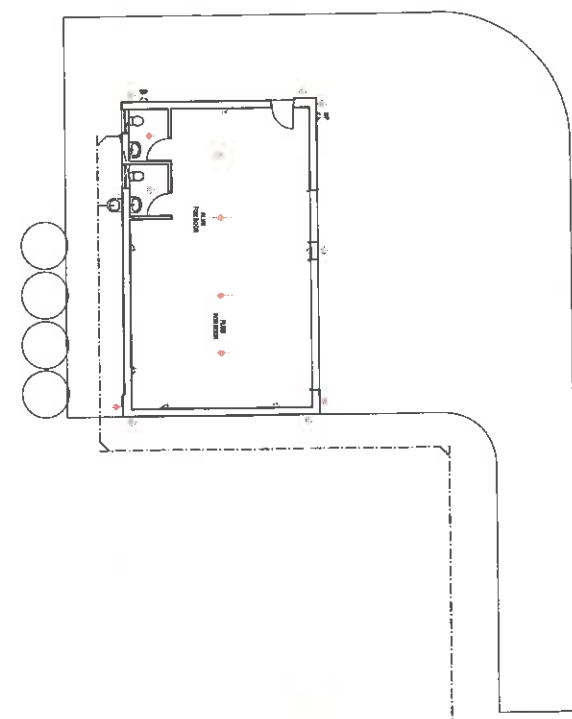

UPPER FLOOR - ELECTRICAL PLANS

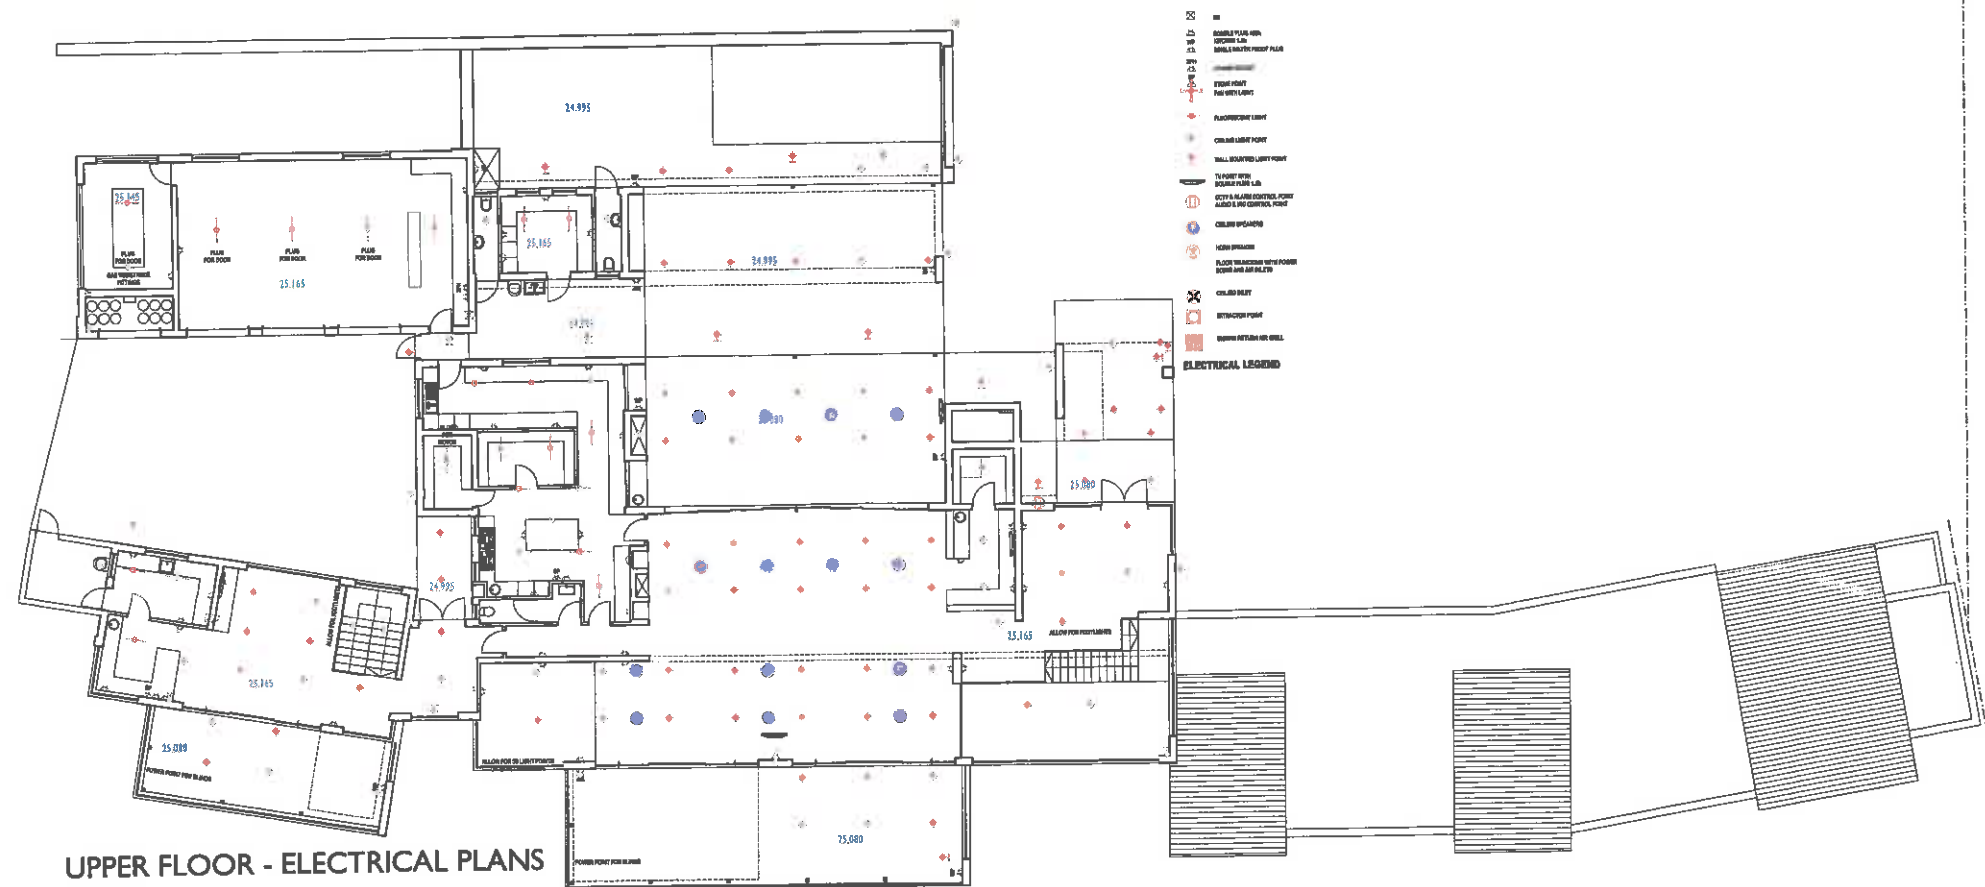

PROJECT NO:	DRAWING NO:	REVISION:
A 21 010	MD07	REV 0

SCANNED

HOUSEHOLD BY SEXUALITY (HOUSEHOLD MEMBERS)

~~ALL INFORMATION CONTAINED HEREIN IS UNCLASSIFIED
DATE 08-19-2010 BY 60322 UCBAW~~

ALL WORK TO COMPLY WITH ACT 140 OF 1977, SAME IS
AND ALL RELEVANT LEGISLATION, CODES, DECISIONS
COMMON CONDITIONS OF APPOINTMENT MUST BE COMPLIED

WINEER

[illegible]

DRAWING STATUS
MUNICIPAL DRAWINGS

PROJECT TITLE
NEW RESIDENTIAL HOUSE
OR NEW BEGINNING 17 (P
LTD - GROOT BRAK
ERF 4 716

DRAWING DESCRIPTION

ELECTRICAL PLANS

DATE	AS SHOWN
DATE	MARCH 2023
DATE	24/03/2023
DATE	RH
DATE	TvdB
DATE	TvdB

HAD
van Hamilton Architectural Design

NTACT: 254-6637 (8Hartland)
hls@hls.net
511 1045 17th St
Hartland, WI 53029

PROJECT NO:	DRAWING NO:	REVISION
A 21 010	MD07	REV 1